

ALTERATIONS

NO	DESCRIPTION	AUTHORITY	BY	DATE	APP'D

REFERENCE PLANS		
NO	TITLE	DATE

GENERAL NOTES	

PRINT RECORD	
NO. PRINTED	
DATE PRINTED	
ALTERATION	
OWNER	
SECTOR	
PROJECT MANAGER	
PROJECT ENGINEER	
PRODUCTION DEPT.	
P&ID DEPT.	
O.A. DEPT.	
PURCHASING DEPT.	
ENGINEERING DEPT.	

APPROVED BY:	
American Bureau of Shipping	
DATE	03-03-2000

ASIAN LIFT PTE. LTD.

DATE: 3-2-1997 SCALE: 1:200
 DESIGNED BY: DEN BOER HULL/JOB No.: B 235
 DRAWN: db/cw ENGR. PROJECT No.:
 CHECKED: DESIGN APPROVED:


JOB: 5200T SHEERLEG CRANE VESSEL
 'ASIAN HERCULES II'

TITLE: HOISTING DIAGRAM

SHEET 1 OF 3 SHEETS
 FES3 PLAN NO.

DRAWING NO.: 2116-37-20

SCALE: A0

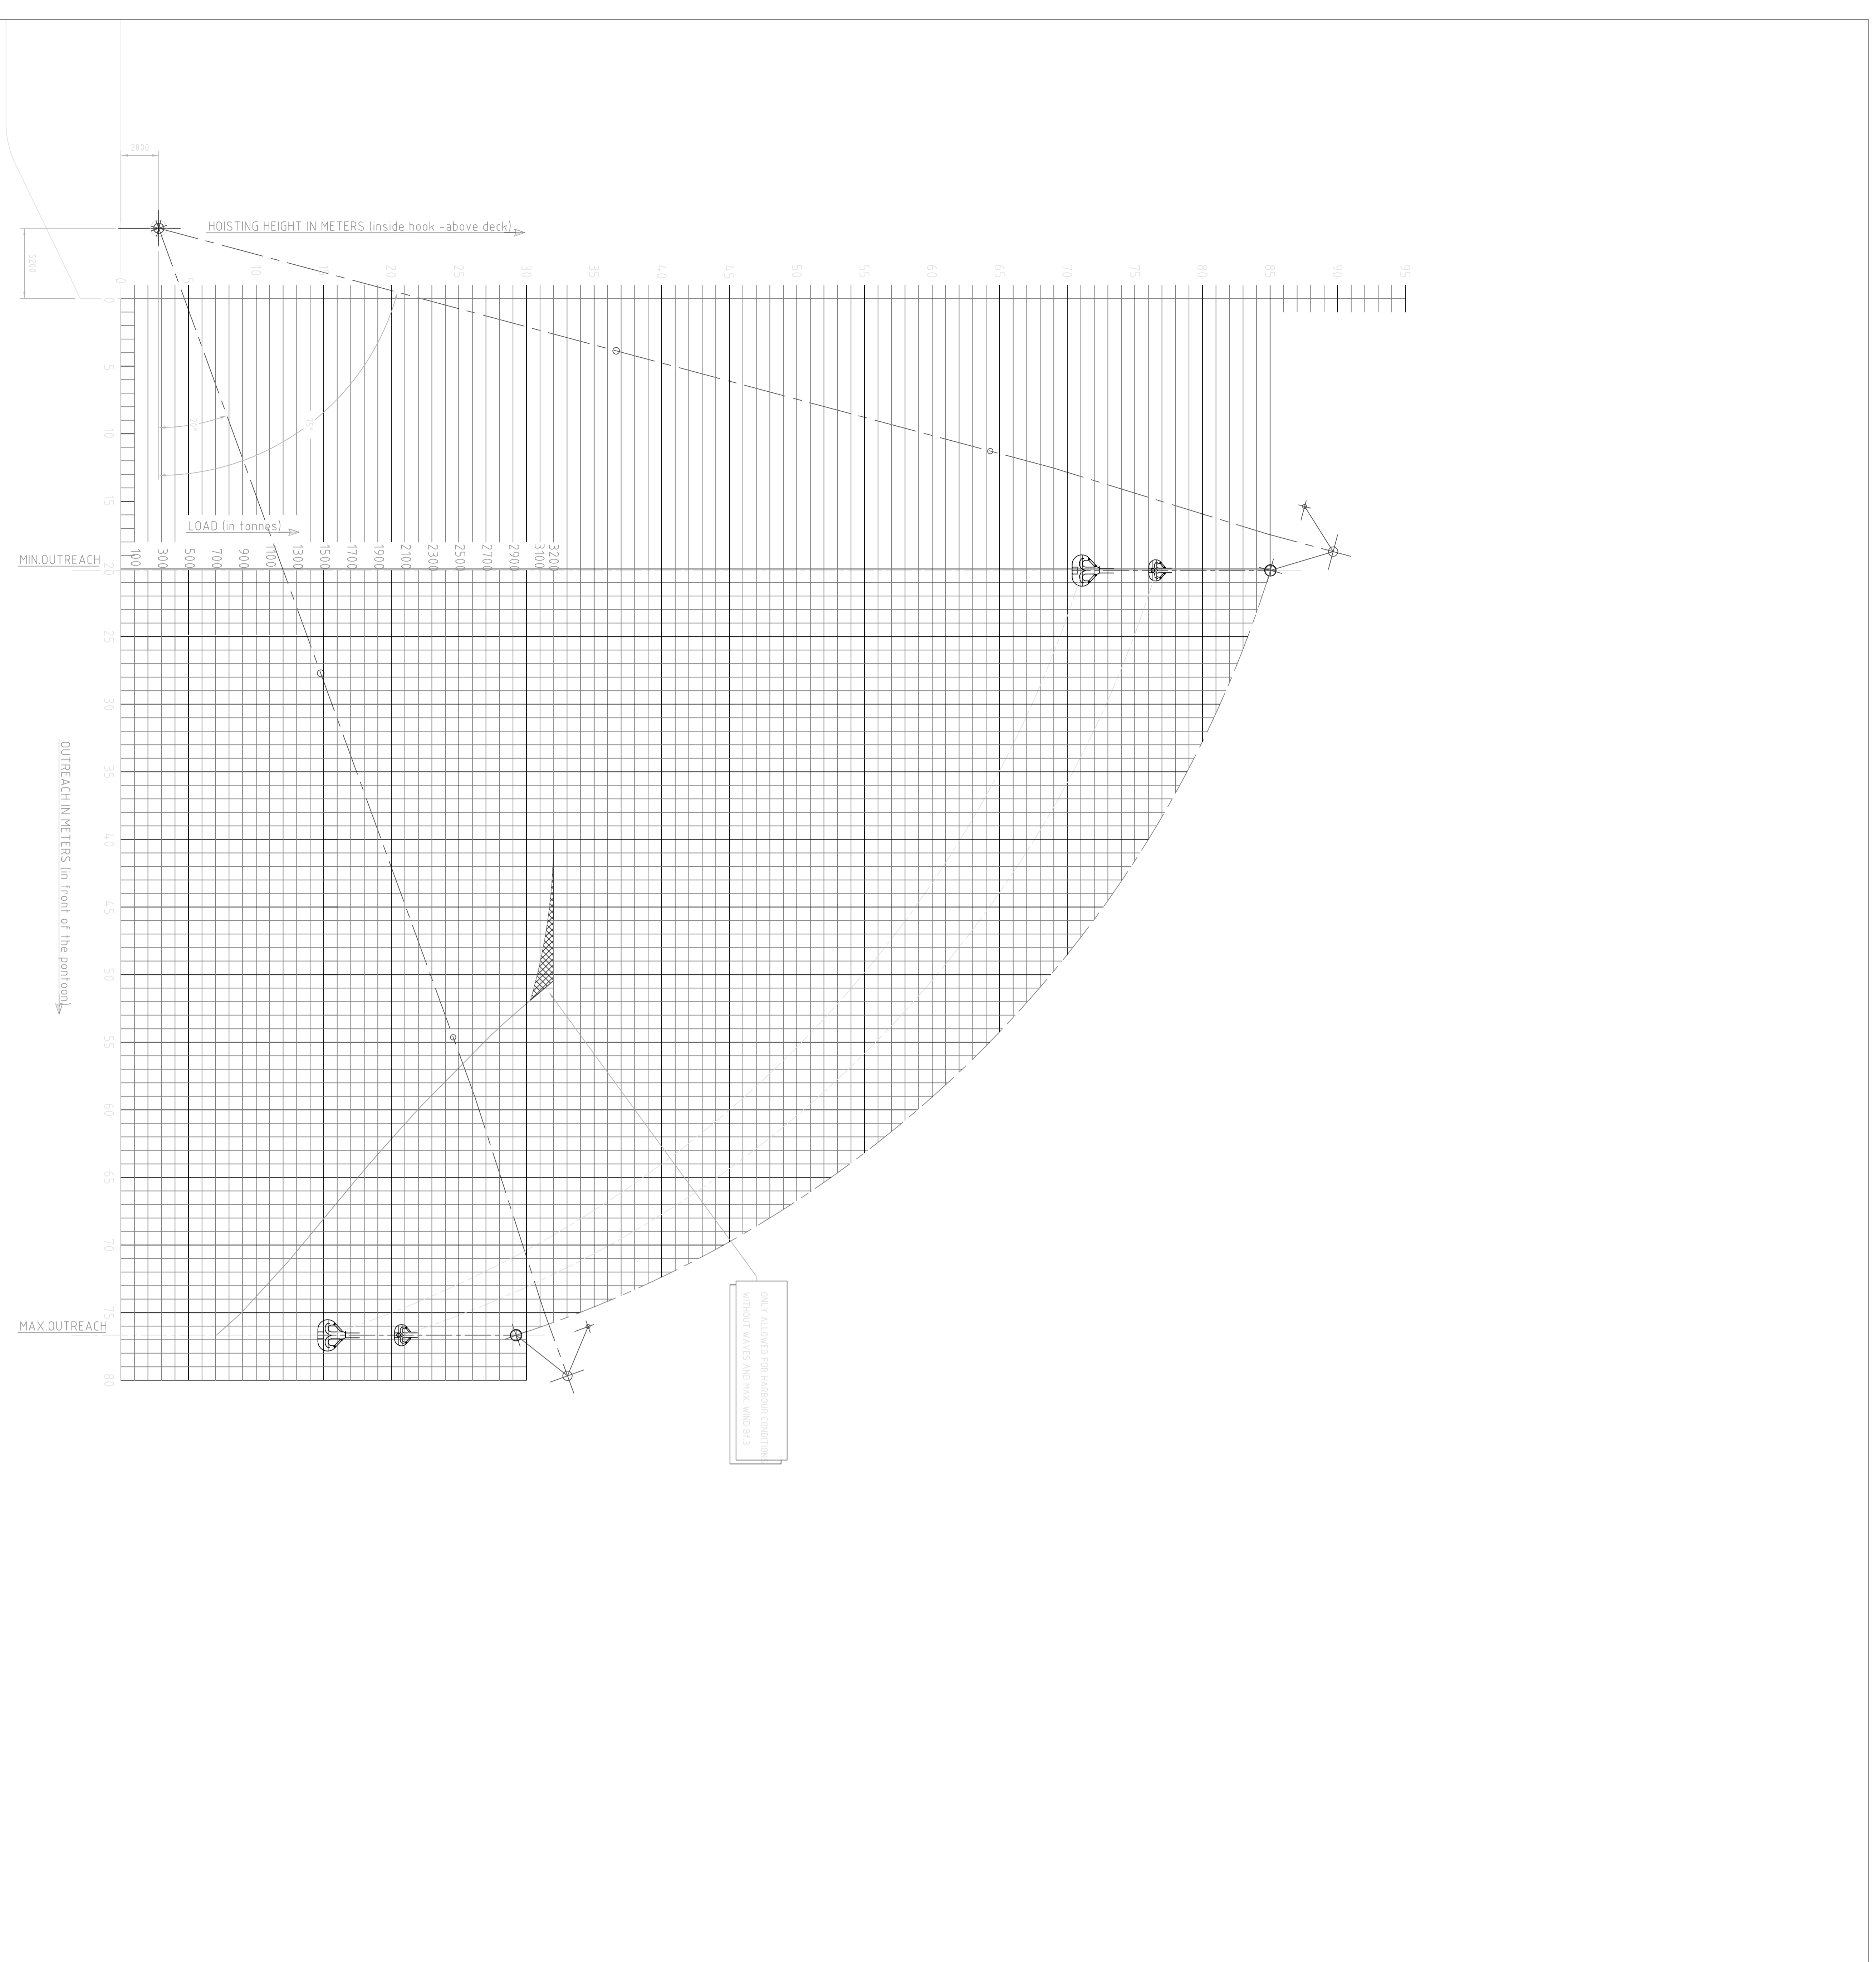

NOTE
 OUTREACH AND HOISTING HEIGHT ARE MEASURED WITH THE POINT ON A TIE-KEEL
 FOUR GULLACKS RIGGED IN A-FRAME AND NO JIB

revision	date	description

project: - INLAND WATERS - A-FRAME IN POSITION 1
 LOAD IN A-FRAME, WITHOUT JIB
 client: bureau voor scheeps- en werk-
 tuigbouw Ir. W. den Boer b.v.
 draag no.: 2116-37-20
 teken no.: 370-200G