

ALTERATIONS

NO	DESCRIPTION	AUTHORITY	BY	DATE	APP'D


REFERENCE PLANS		
NO	TITLE	DATE

GENERAL NOTES	

PRINT RECORD	
NO. PRINTED	
DATE PRINTED	
ALTERATION	
OWNER	
SECTOR	
PROJECT MANAGER	
PROJECT ENGINEER	
PRODUCTION DEPT.	
P&ID DEPT.	
QA DEPT.	
PURCHASING DEPT.	
ENGINEERING DEPT.	

APPROVED BY:	
American Bureau of Shipping	
DATE	03-03-2000

ASIAN LIFT PTE. LTD.	
DATE	12-12-1995
DESIGNED BY	DNB/BOER
DRAWN	db/gw
CHECKED	
JOB	5200T SHEERLEG CRANE VESSEL
TITLE	HOISTING DIAGRAM
SHEET	1 OF 1 SHEETS
DRAWING NO.	FES3 PLAN NO.

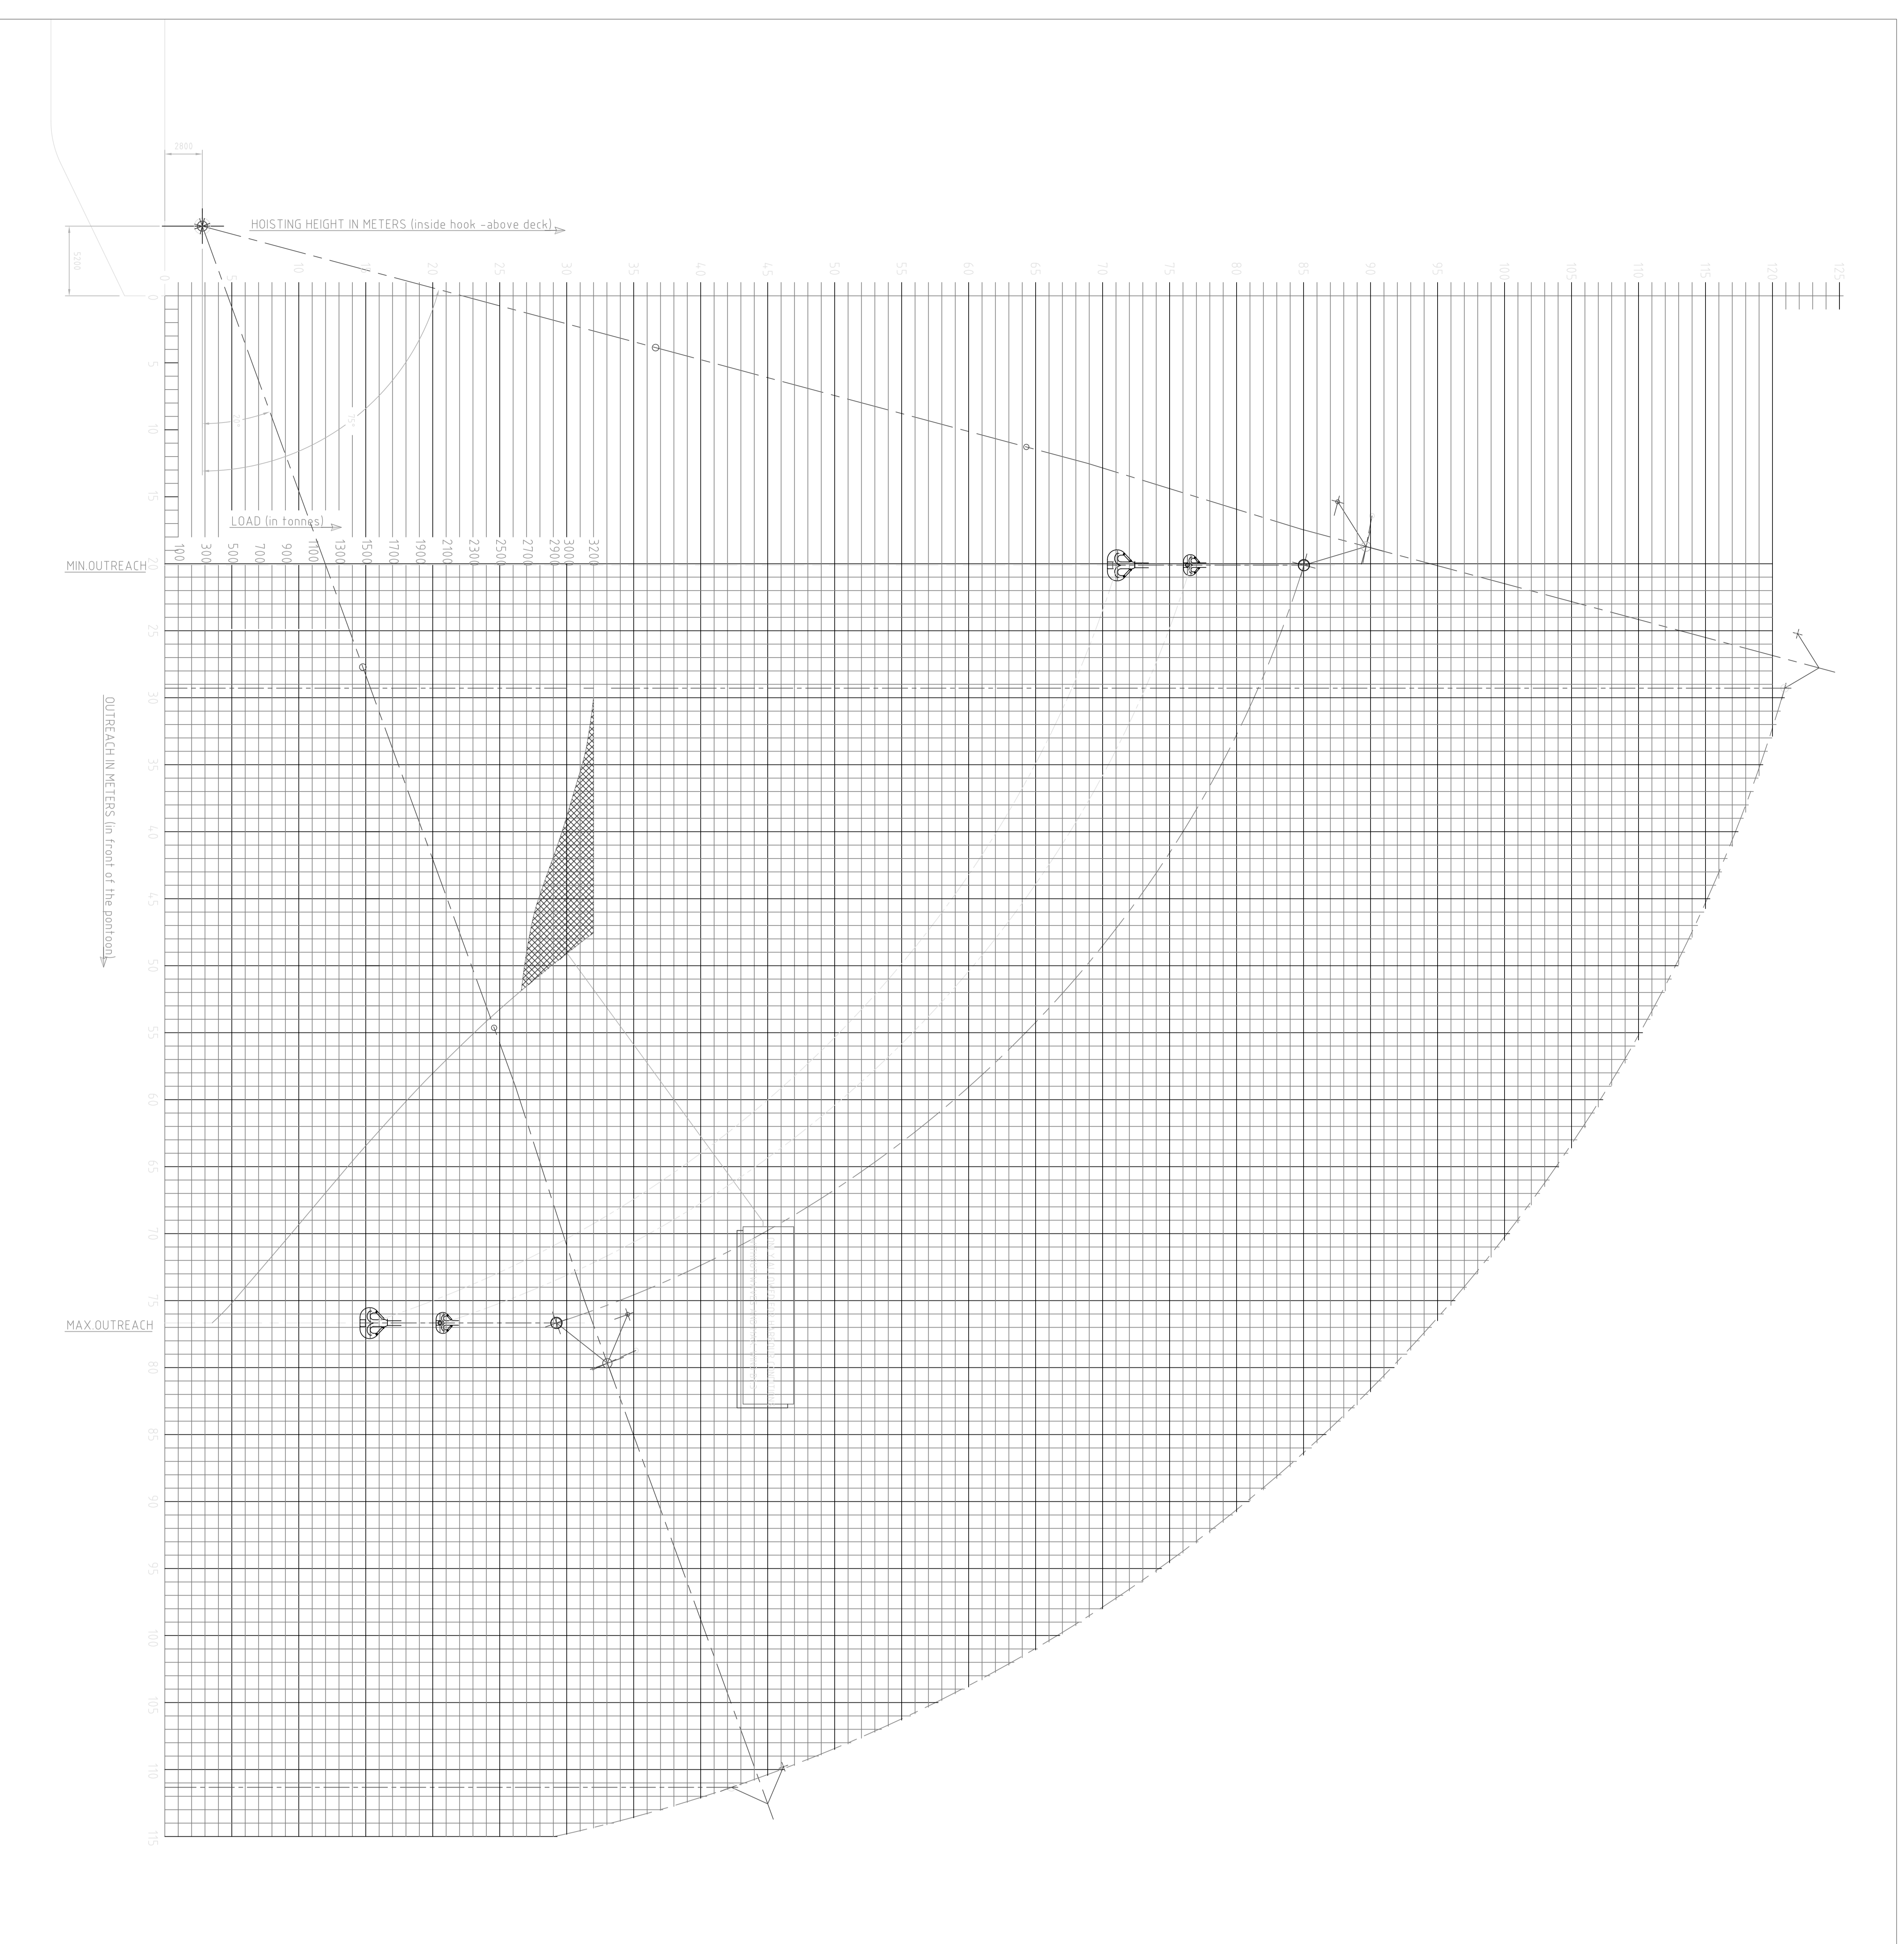

NOTE
 OUTREACH AND HOISTING HEIGHT ARE MEASURED WITH THE POINT ON A TIE-KEEL
 FOUR (4) TACKLES RIGGED IN A-FRAME AND NO TACKLES IN JIB

revision	date	description

project	31- EAST LEVINOSTON SHIPQUAY
part	31- CALCULATIONS - HOISTING DIAGRAMS
date	12-28-1995
drawn	DNB/BOER
checked	
scale	1:200
revision	3712B/DWG

revision	
date	2116-37-21
revision	