

ALTERATIONS

NO	DESCRIPTION	AUTHORITY	BY	DATE	APP'D
----	-------------	-----------	----	------	-------


REFERENCE PLANS					
NO	TITLE	DB	FELS	PLAN NO	PLAN BY

GENERAL NOTES					
---------------	--	--	--	--	--

PRINT RECORD					
NO. PRINTED		DATE PRINTED			
ALTERATION		OWNER			
SECTOR		SECTOR MANAGE. DEPT.			
PROJECT MANAGER		PROJECT ENGINEER			
PRODUCTION DEPT.		P&ID DEPT.			
P&ID DEPT.		QA DEPT.			
PURCHASING DEPT.		ENGINEERING DEPT.			

ASIAN LIFT PTE. LTD.					
DATE :	3-2-1997	SCALE :	1:200		
DESIGNED BY :	DEN BOER	HULL/JOB No. :	B 235		
CHECKED :		ENGR. PROJECT No. :			
JOB :	5200T SHEERLEG CRANE VESSEL				
TITLE :	HOISTING DIAGRAM				
FELS PLAN NO. :	SHEET 1 OF 1 SHEETS				
DRAWING NO. :	2116-37-31				

ASIAN LIFT PTE. LTD.					
DATE :	3-2-1997	SCALE :	1:200		
DESIGNED BY :	DEN BOER	HULL/JOB No. :	B 235		
CHECKED :		ENGR. PROJECT No. :			
JOB :	5200T SHEERLEG CRANE VESSEL				
TITLE :	HOISTING DIAGRAM				
FELS PLAN NO. :	SHEET 1 OF 1 SHEETS				
DRAWING NO. :	2116-37-31				

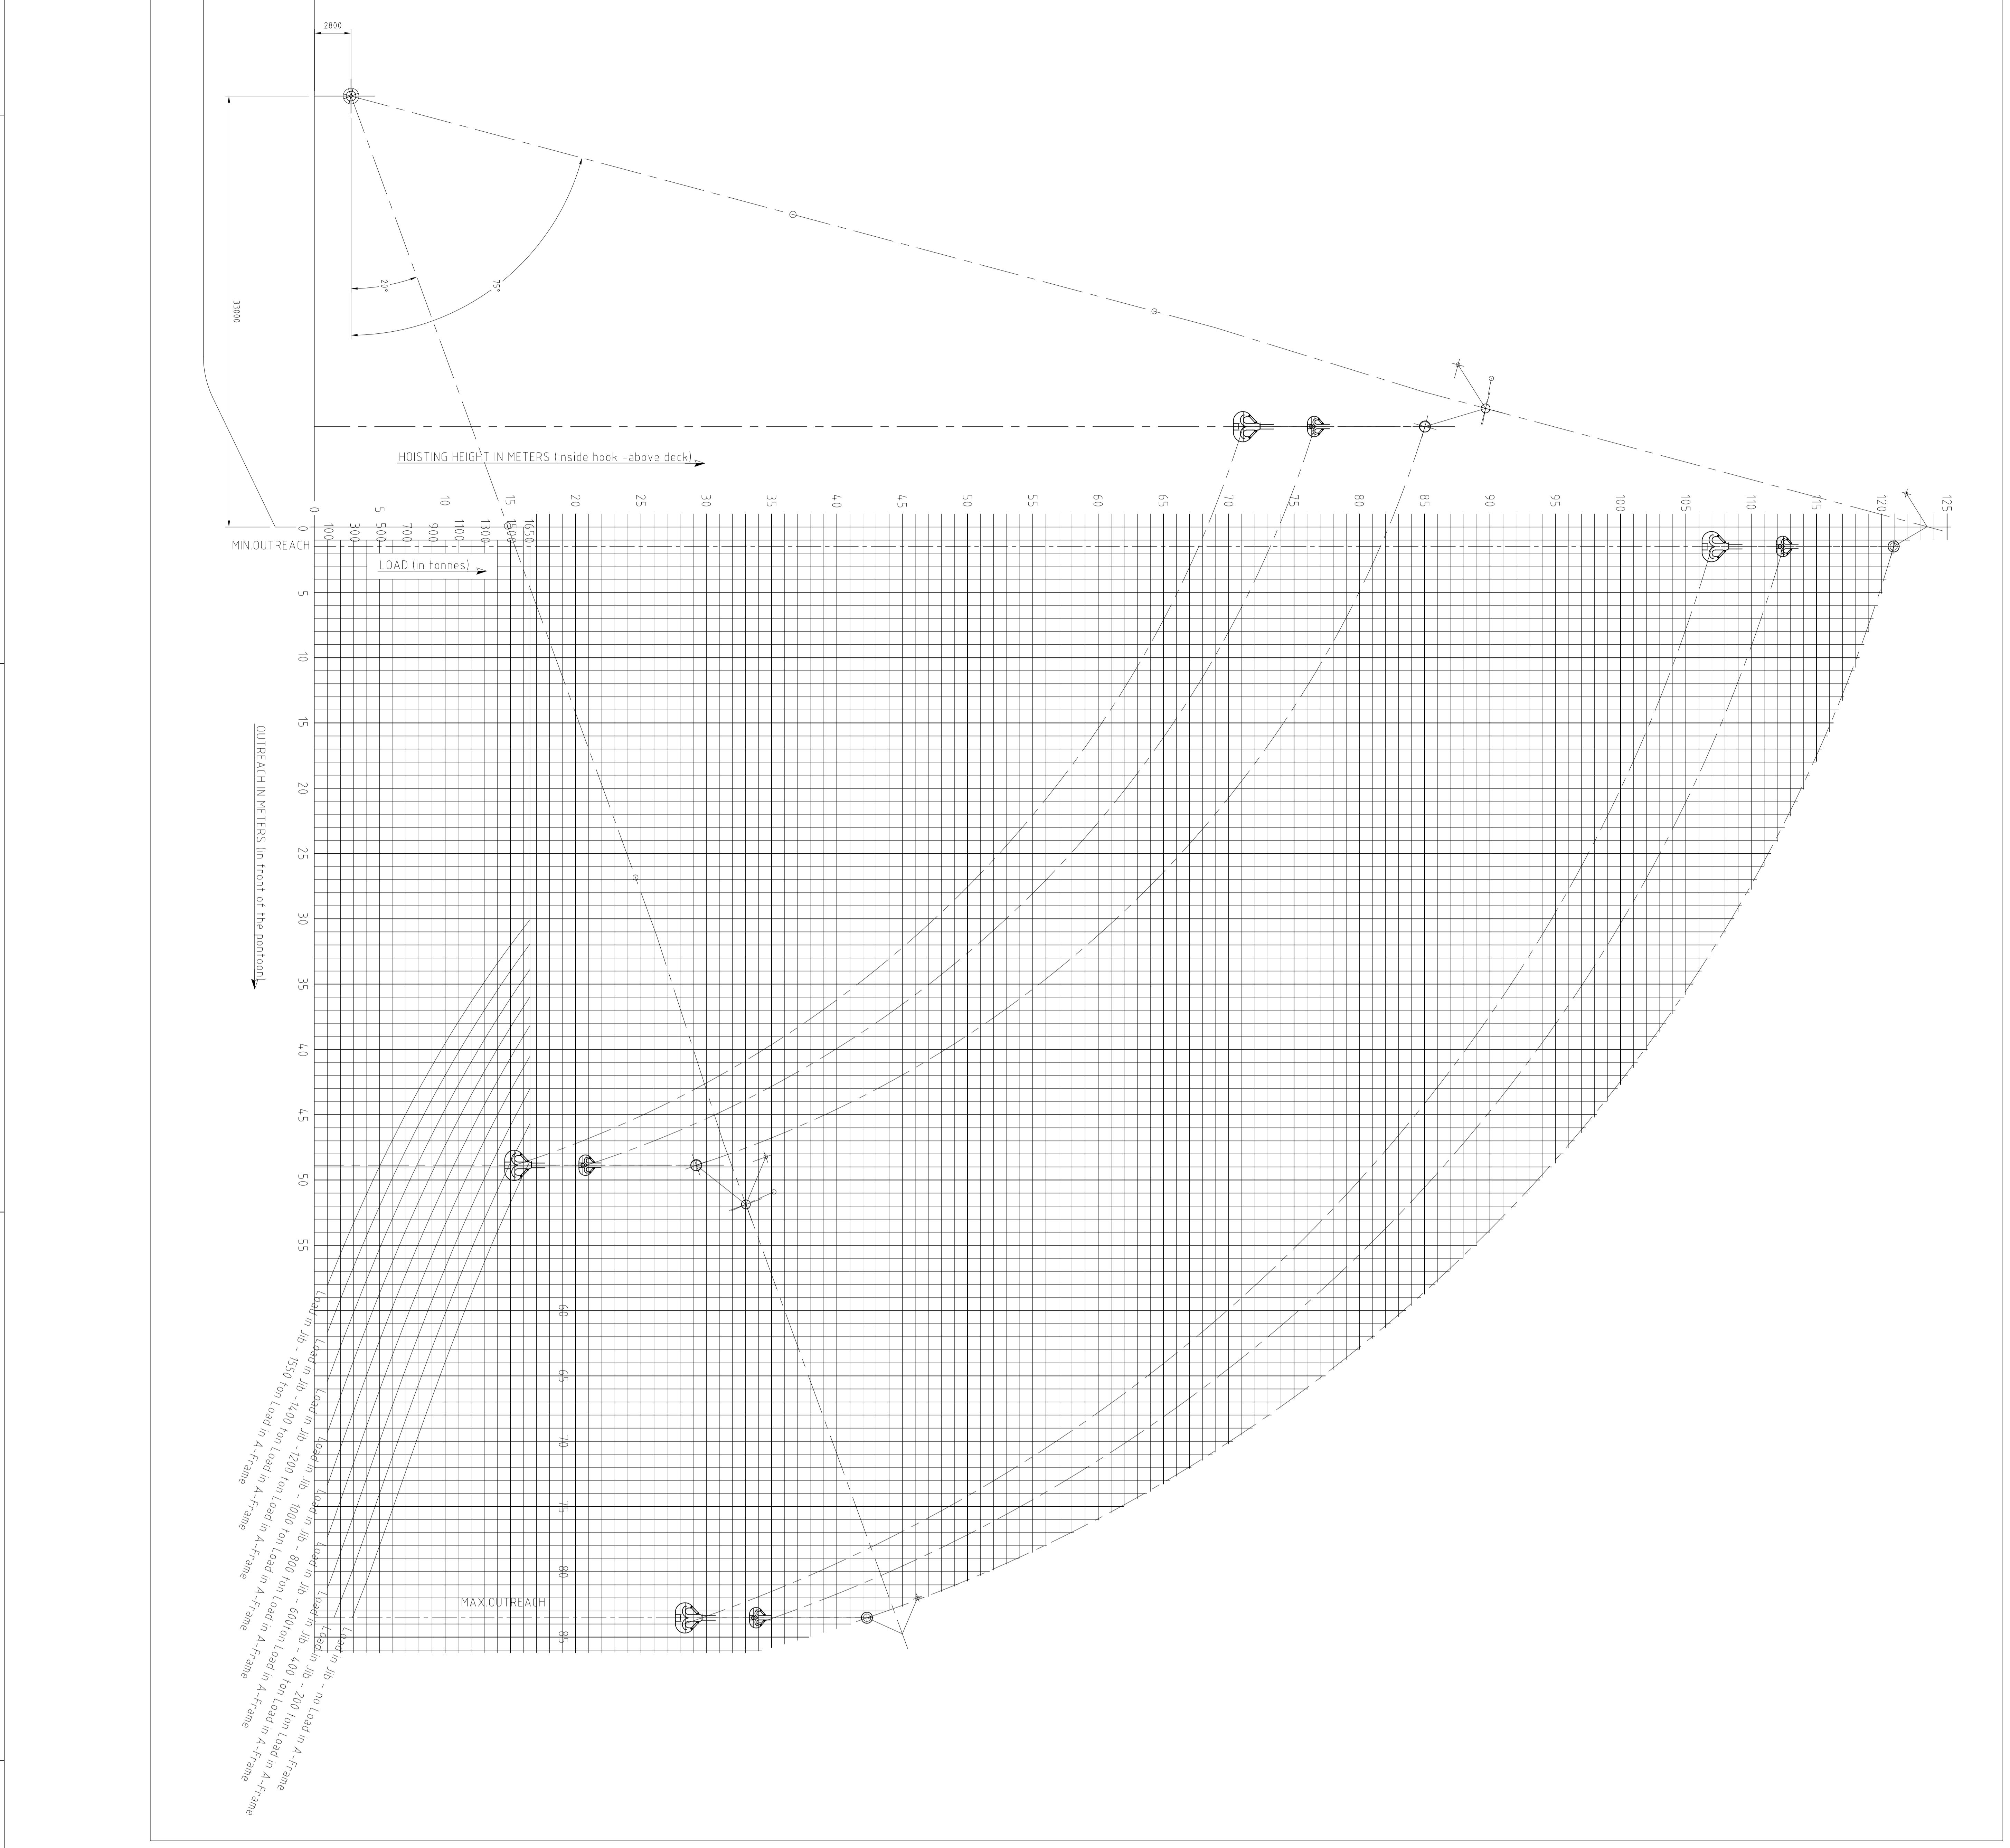

NOTE

OUTREACH AND HOISTING HEIGHT ARE MEASURED WITH THE POINT ON A T-EVEN KEEL

TWO TACKLES RIGGED IN A-FRAME AND TWO TACKLES RIGGED IN JIB

revision	date	description
B	03-03-2000	REVISED

approved	date	revision	name
			ABE APPROVAL

project	part	date	ident. to ship no.	drawn	checked	scale	format
dib	37 - CALCULATIONS - HOISTING DIAGRAMS	3-2-1997		den boer	den boer	1:200	A0
revision: 373B/DWG							

company: dib bureau voor scheeps- en werk- tuigbouw ir. w. den boer b.v. (netherlands)

designed by: den boer

project: 5200 T SHEERLEG CRANE VESSEL ASIAN HERCULES II

part: 37 - CALCULATIONS - HOISTING DIAGRAMS

date: 3-2-1997

ident. to ship no.: 2116-37-31

drawn: den boer

checked: den boer

scale: 1:200

format: A0